

INDEX OF PLANS


SHEET No.	DESCRIPTION
1	TITLE AND LOCATION MAP
2-4	CONSTRUCTION DETAILS
5-9	TEMPORARY WATER POLLUTION CONTROL PLANS AND QUANTITIES
10-17	UTILITY PLANS
18-20	CONSTRUCTION AREA SIGNS
21	SIGNS
22	SUMMARY OF QUANTITIES
23-36	PLANTING PLANS
37-42	ELECTRICAL PLANS

STATE OF CALIFORNIA
DEPARTMENT OF TRANSPORTATION

PROJECT PLANS FOR CONSTRUCTION ON
STATE HIGHWAY
IN ALAMEDA COUNTY
IN SAN LEANDRO

AT MARINA BOULEVARD OVERCROSSING AND DAVIS STREET OVERCROSSING

TO BE SUPPLEMENTED BY STANDARD PLANS DATED 2018

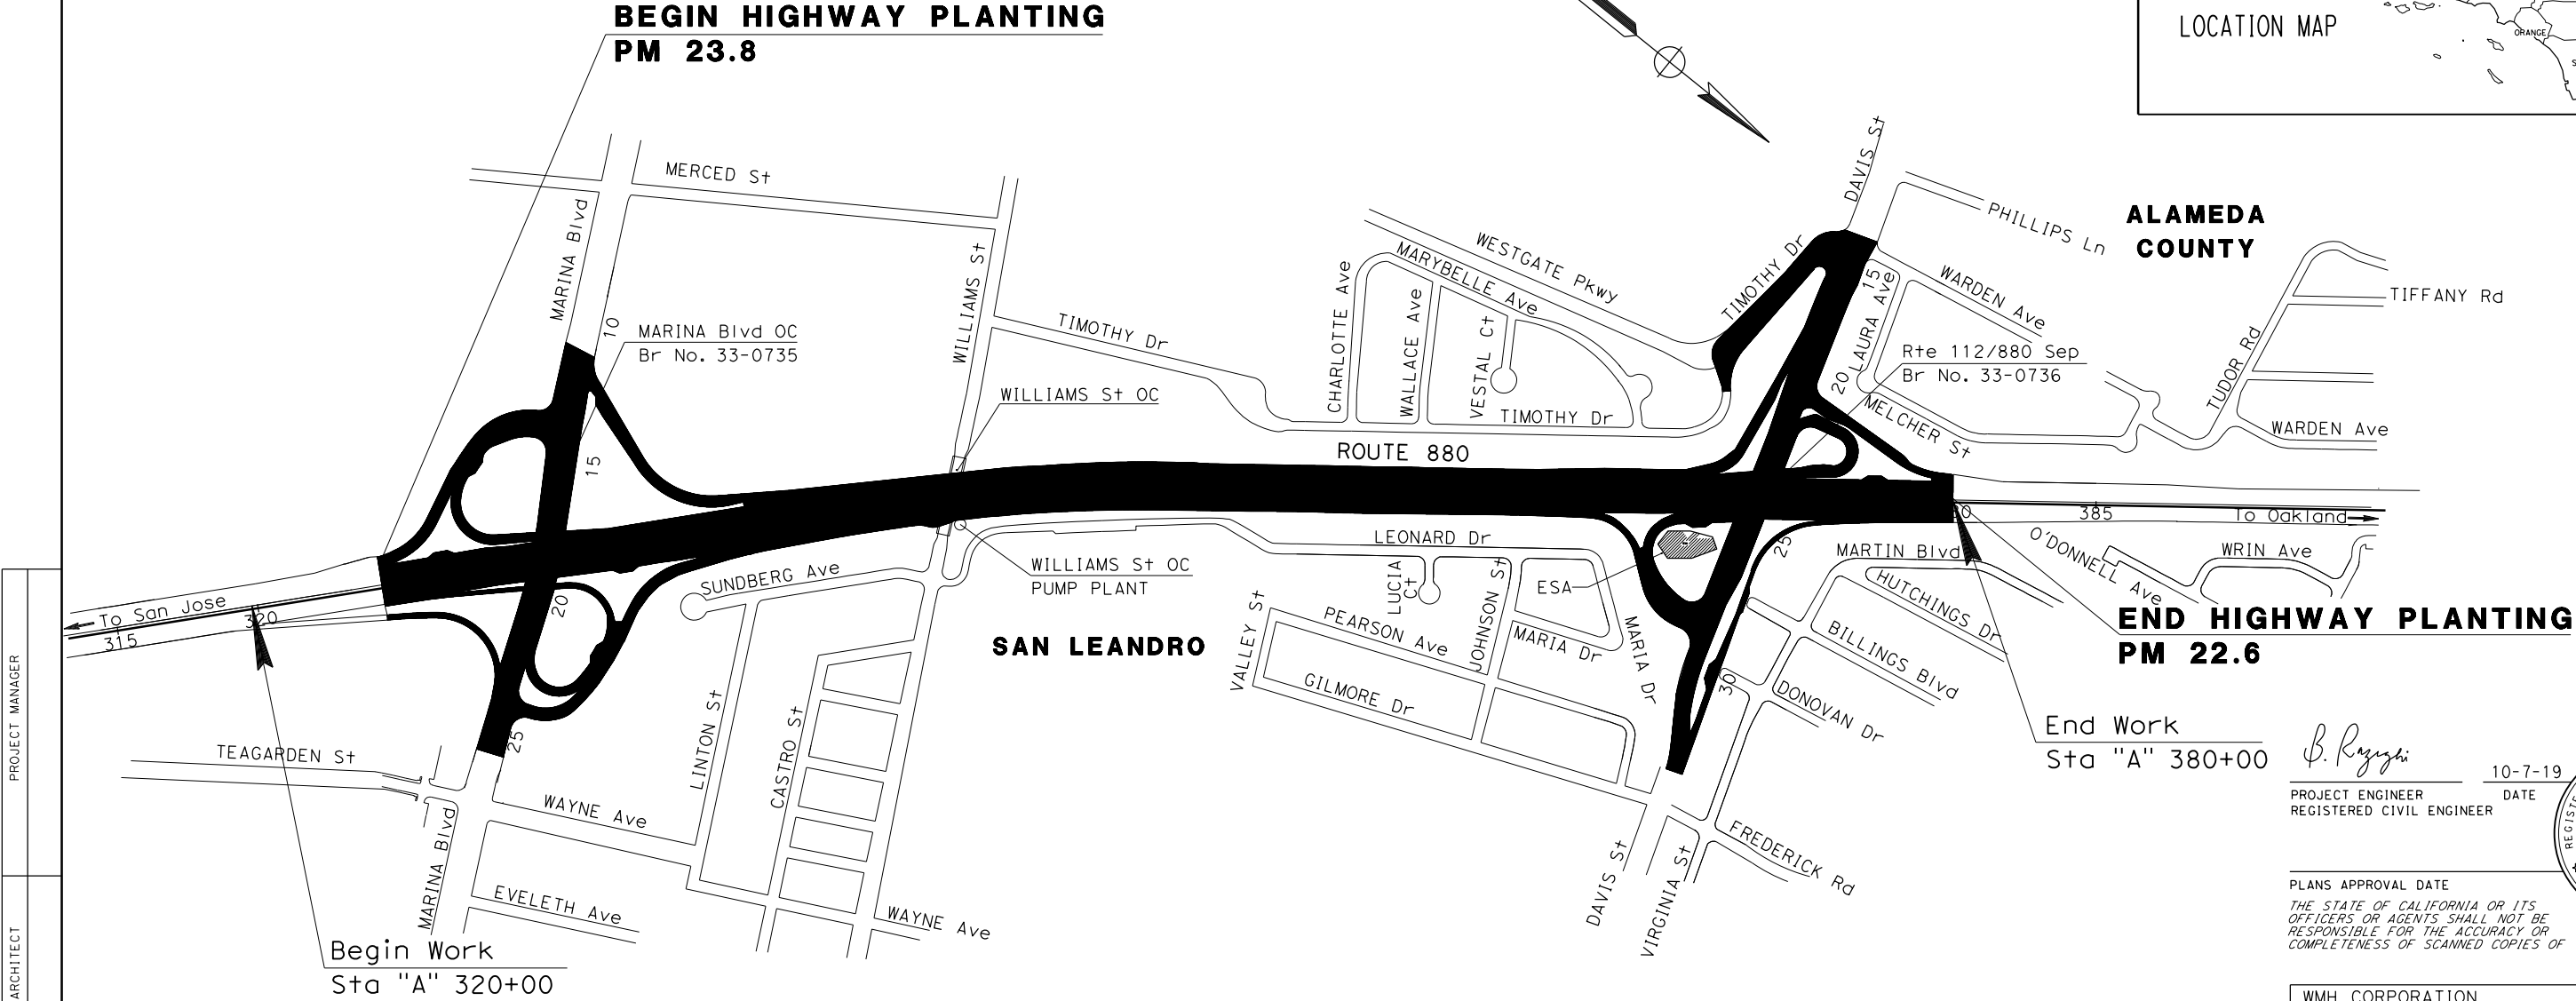

PROJECT MANAGER
SENIOR LANDSCAPE ARCHITECT


THE CONTRACTOR SHALL POSSESS THE CLASS (OR CLASSES)
OF LICENSE AS SPECIFIED IN THE "NOTICE TO BIDDERS."

NO SCALE

Attachment A

ALAMEDA CTC PROJECT NO. **1376001**

B. Razezgi
PROJECT ENGINEER
REGISTERED CIVIL ENGINEER
DATE 10-7-19
PLANS APPROVAL DATE
THE STATE OF CALIFORNIA OR ITS
OFFICERS OR AGENTS SHALL NOT BE
RESPONSIBLE FOR THE ACCURACY OR
COMPLETENESS OF SCANNED COPIES OF THIS PLAN SHEET.

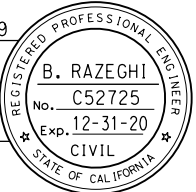

WMH CORPORATION
55 South Market Street, Suite 1200
San Jose, CA 95113
ALAMEDA COUNTY TRANSPORTATION COMMISSION (ACTC)
1111 Broadway, Suite 800
Oakland, CA 94607

CONTRACT No.	04-3A9231
PROJECT ID	0413000126